

3.0 **G1&WG//LightingPlan**
Scale: 1:50



Metro Arts

Gallery 1 & Window Gallery

Lighting Plan

Metro Arts, 97 Boundary Street, West End, 4101

Scale: 1:50 @ A3 | Version: 1.1 | Updated: 034/06/24


Drawn by:
Nathaniel Knight
0474 477 555
nathaniel@metroarts.com.au

NOTES:

- Measurements in millimeters.
- Metro Arts has 3x lighting systems; Track Lights (warm white), Strip Light (cold white), Downlights (warm white).
- Window Gallery has been drawn as open to show physical relation of lights to wall.
- Beside Gallery 1 entrance there are Strip lights shining onto the East Wall for vinyl placement - They have variable colour temp control.

Symbols:

- Track Light Rail
- Strip Lights
- Downlights

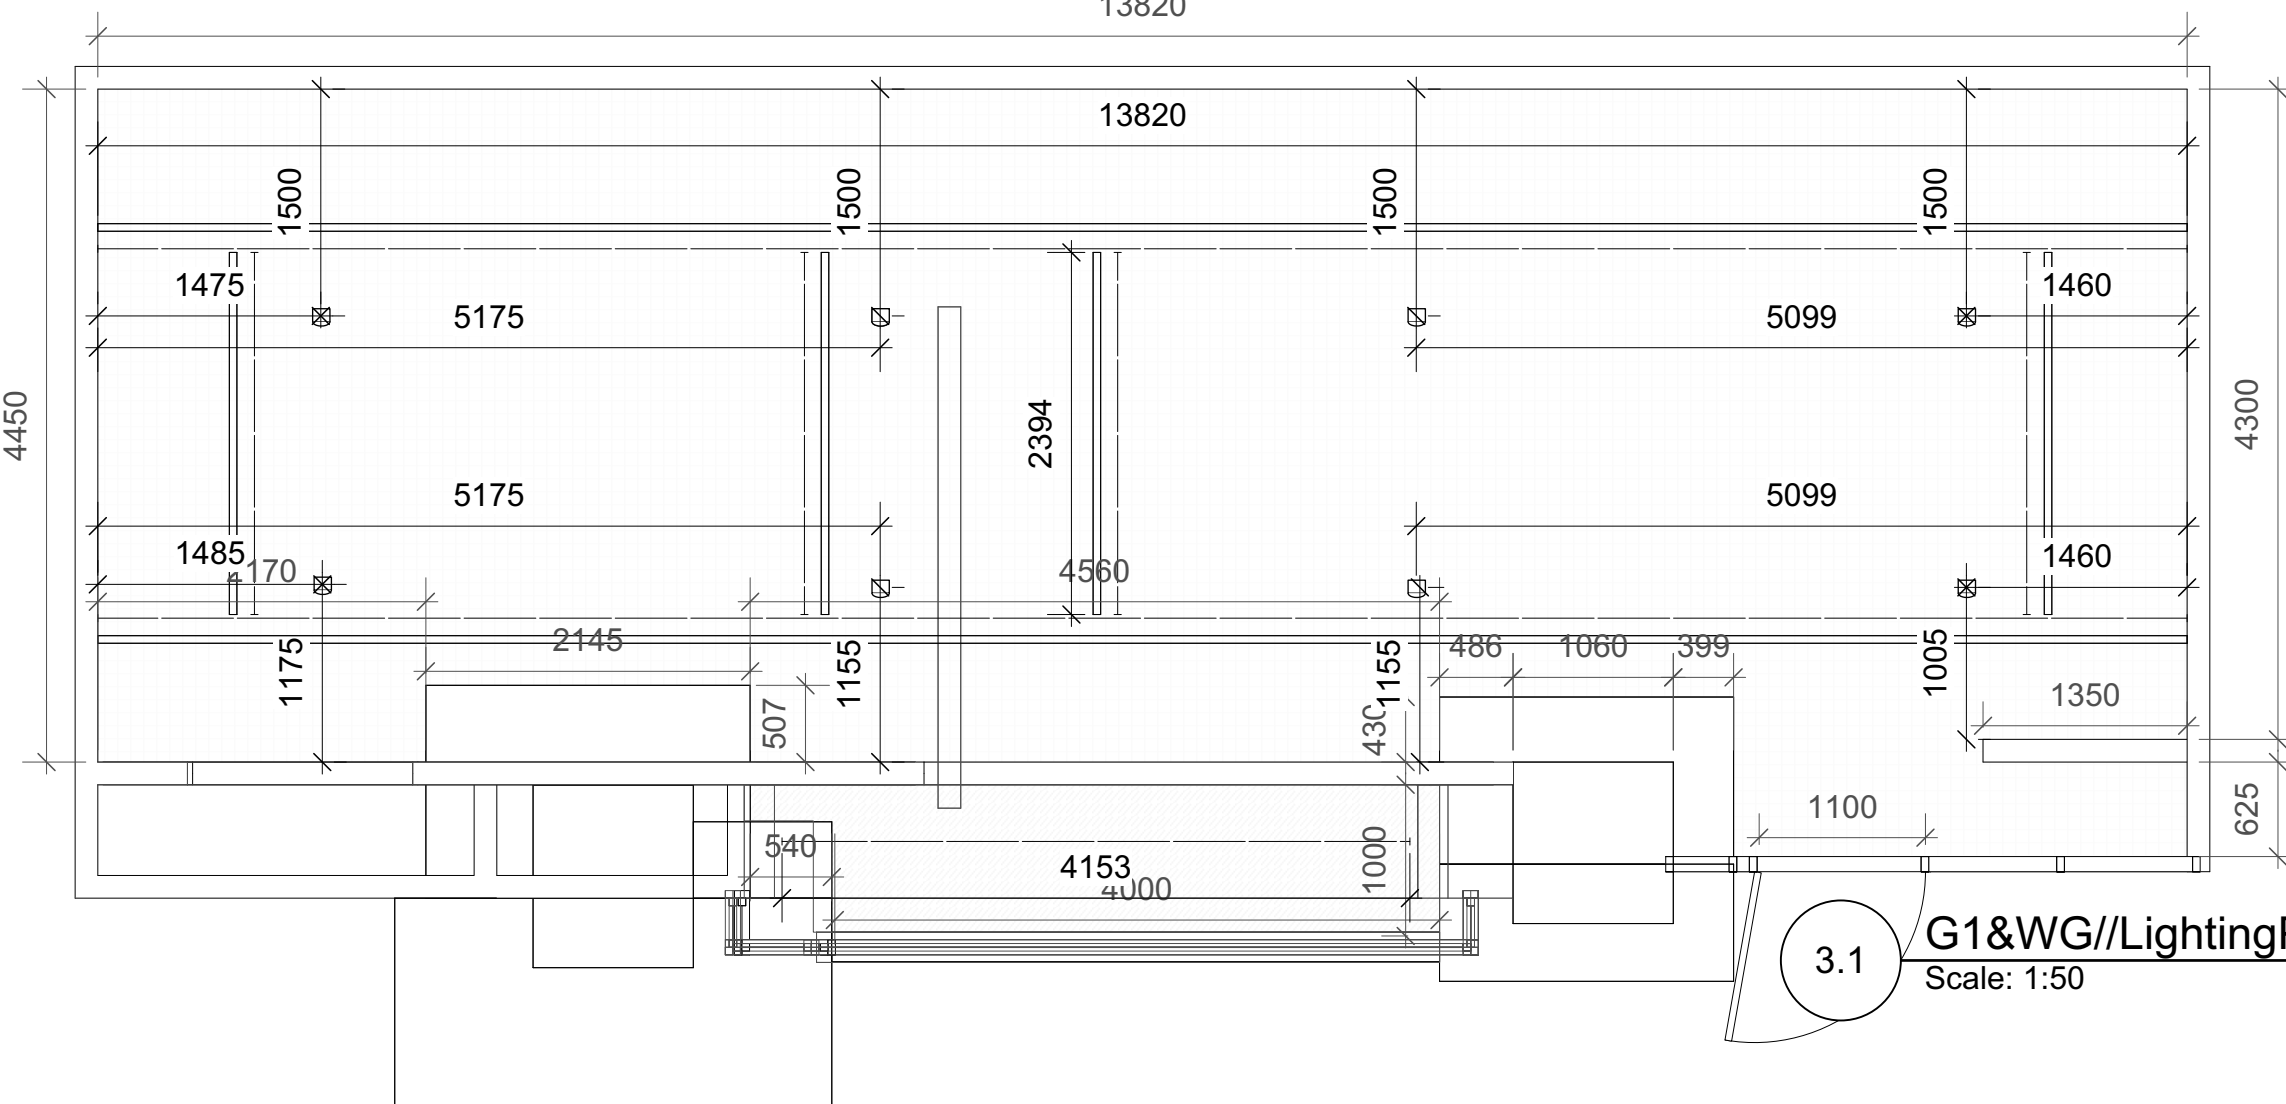

3.1 **G1&WG//LightingPlan+Dimensions**
Scale: 1:50